


To be read in conjunction with below ground drainage setting out schedule AL(5)504

Drainage key:

- Surface water drainage
- Foul water drainage

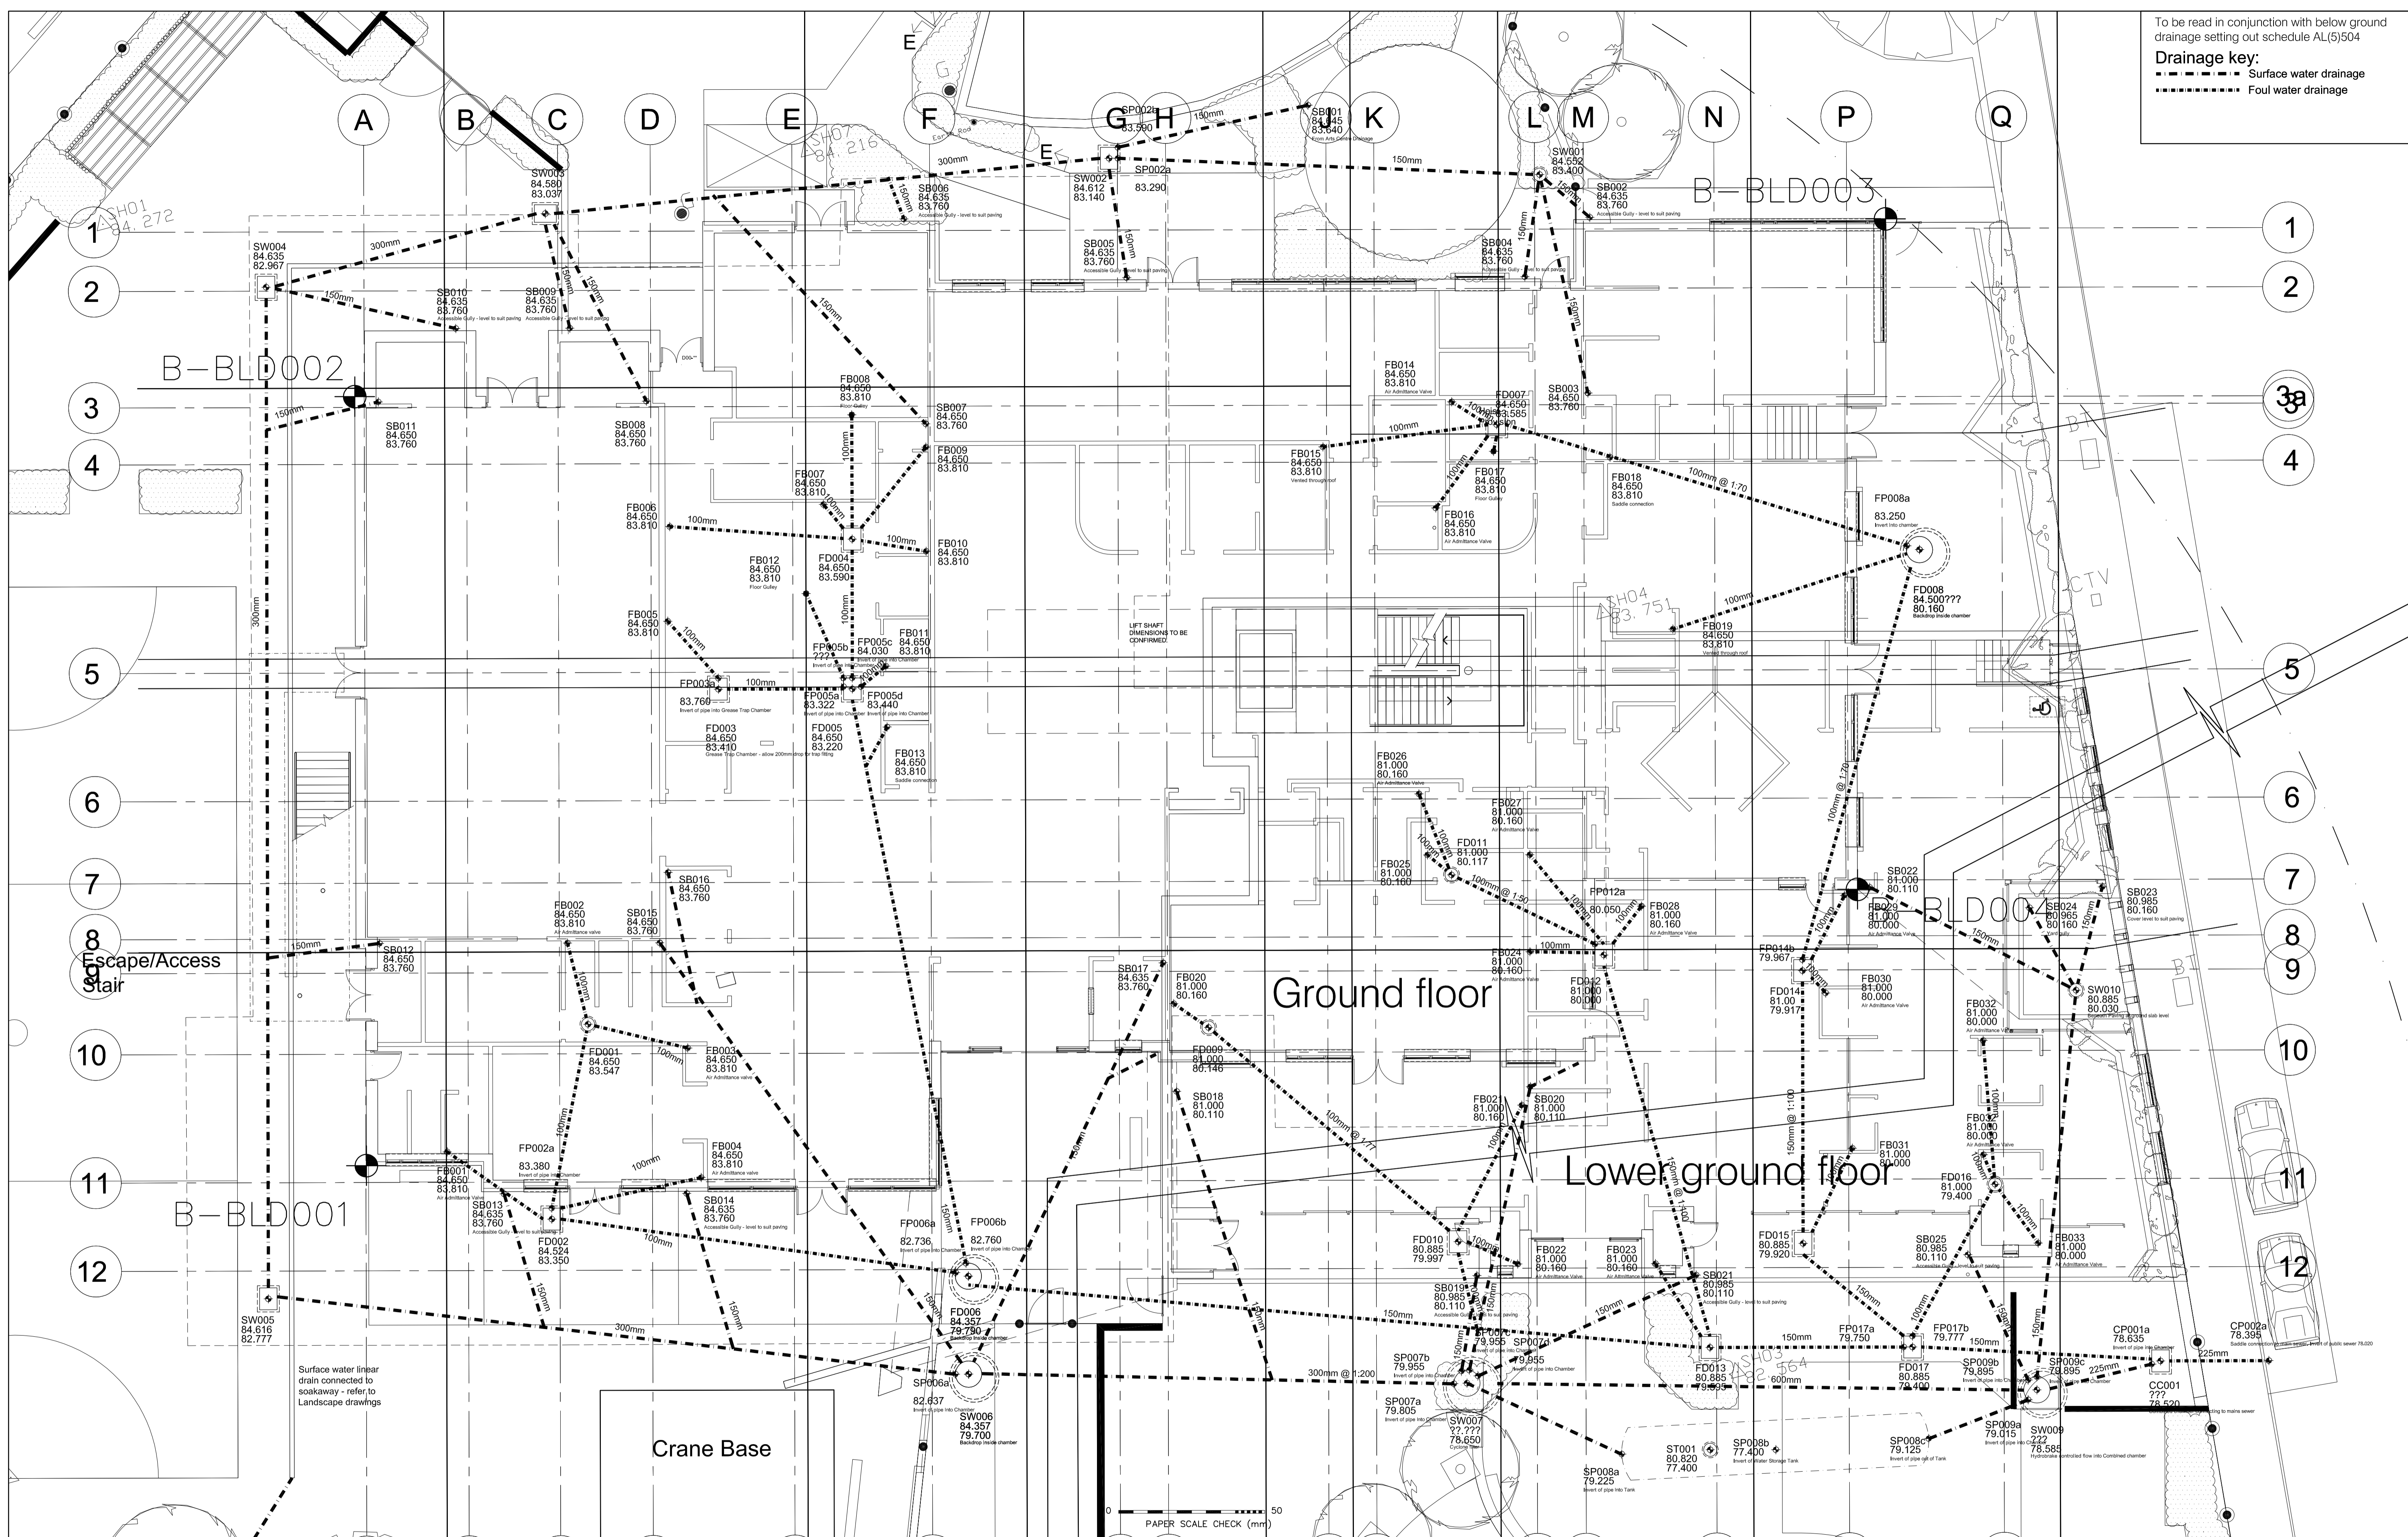

Design and Project Management Architects Division

2-10 CARBROOK HALL ROAD SHEFFIELD S9 2DB
Tel. 0114 2736036 Fax. 0114 2736299 Email. architects@sheffield.gov.uk

Design & Project Management. Head of Service I G Taylor AFICS

- Do not scale from this drawing
- All dimensions to be checked on site
- Any errors /omissions to be reported immediately
- If in doubt, ask
- No reproduction of this drawing in any form without permission
- Maps are reproduced from Ordnance Survey with permission of HMSO Crown copyright

REV	DATE	REVISIONS	DRAWN	CHECKED	NOTES
*	****	*****	***	***	

CLIENT:	EDUCATION DIRECTORATE
SCHEME:	SHARROW NEW BUILD NIJ
TITLE:	PROPOSED BELOW GROUND DRAINAGE LAYOUT

STATUS:	CONSTRUCTION	A1
SCHEME NO	DWG NO.	REV
ED00747	AL (5) 500	

PDF processed with Cutler PDF evaluation edition - www.CutlerPDF.com